

LIGHT FIXTURE SCHEDULE

- A CEILING RECESSED DOWNLIGHT
- B WALL MOUNTED STRIP FIXTURE
- C SURFACE MOUNTED CEILING FIXTURE
- D PENDANT MOUNTED DOWNLIGHT
- E CEILING RECESSED SPOT LIGHT
- F PENDANT MOUNTED CHANDELIER
- G WALL MOUNTED SCONCE
- H CEILING MOUNTED FIXTURE AT GARAGE
- I WALL MOUNTED EXTERIOR FIXTURE
- J LINEAR UNDERCABINET FIXTURE
- K CEILING MOUNTED UTILITY LIGHT
- L WALL MOUNTED UTILITY LIGHT

SYMBOLS LEGEND

- ⊕ DUPLEX ELECTRIC OUTLET
- GFI ⊕ GROUND FAULT CIRCUIT INTERRUPT OUTLET
- ⊕ SWITCHED OUTLET
- ⊕ QUAD ELECTRIC OUTLET
- WF ⊕ WATERPROOF ELECTRIC OUTLET
- ⊕ SPECIAL ELECTRIC CONNECTION OR APPLIANCE
- ⊕ FLOOR RECESSED DUPLEX ELECTRIC OUTLET
- S SWITCH
- ⊕ DIMMER SWITCH
- ◇ DOOR JAMB SWITCH
- ⊕ LIGHT FIXTURE
- ⊕ WALL WASHER LIGHT
- STRIP LIGHT (UNDERCABINET, COVE)
- ⊕ CEILING FAN
- ⊕ SMOKE & CARBON MONOXIDE DETECTOR
- ⊕ EX-HASUT FAN


Residence

6600 Chesterfield Avenue
McLean, Virginia


NOVITSKE ARCHITECTS

201 North Fairfax Street • Suite 33
Alexandria VA 22314
703 535 7899 • 703 535 8840 fax


graphic scales

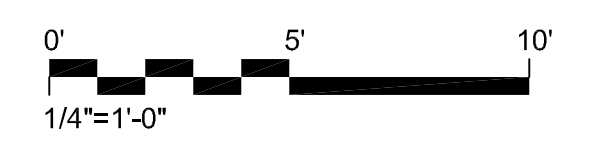

project: 23612
phase: Permit Set
date: 16 January 2017
revisions:

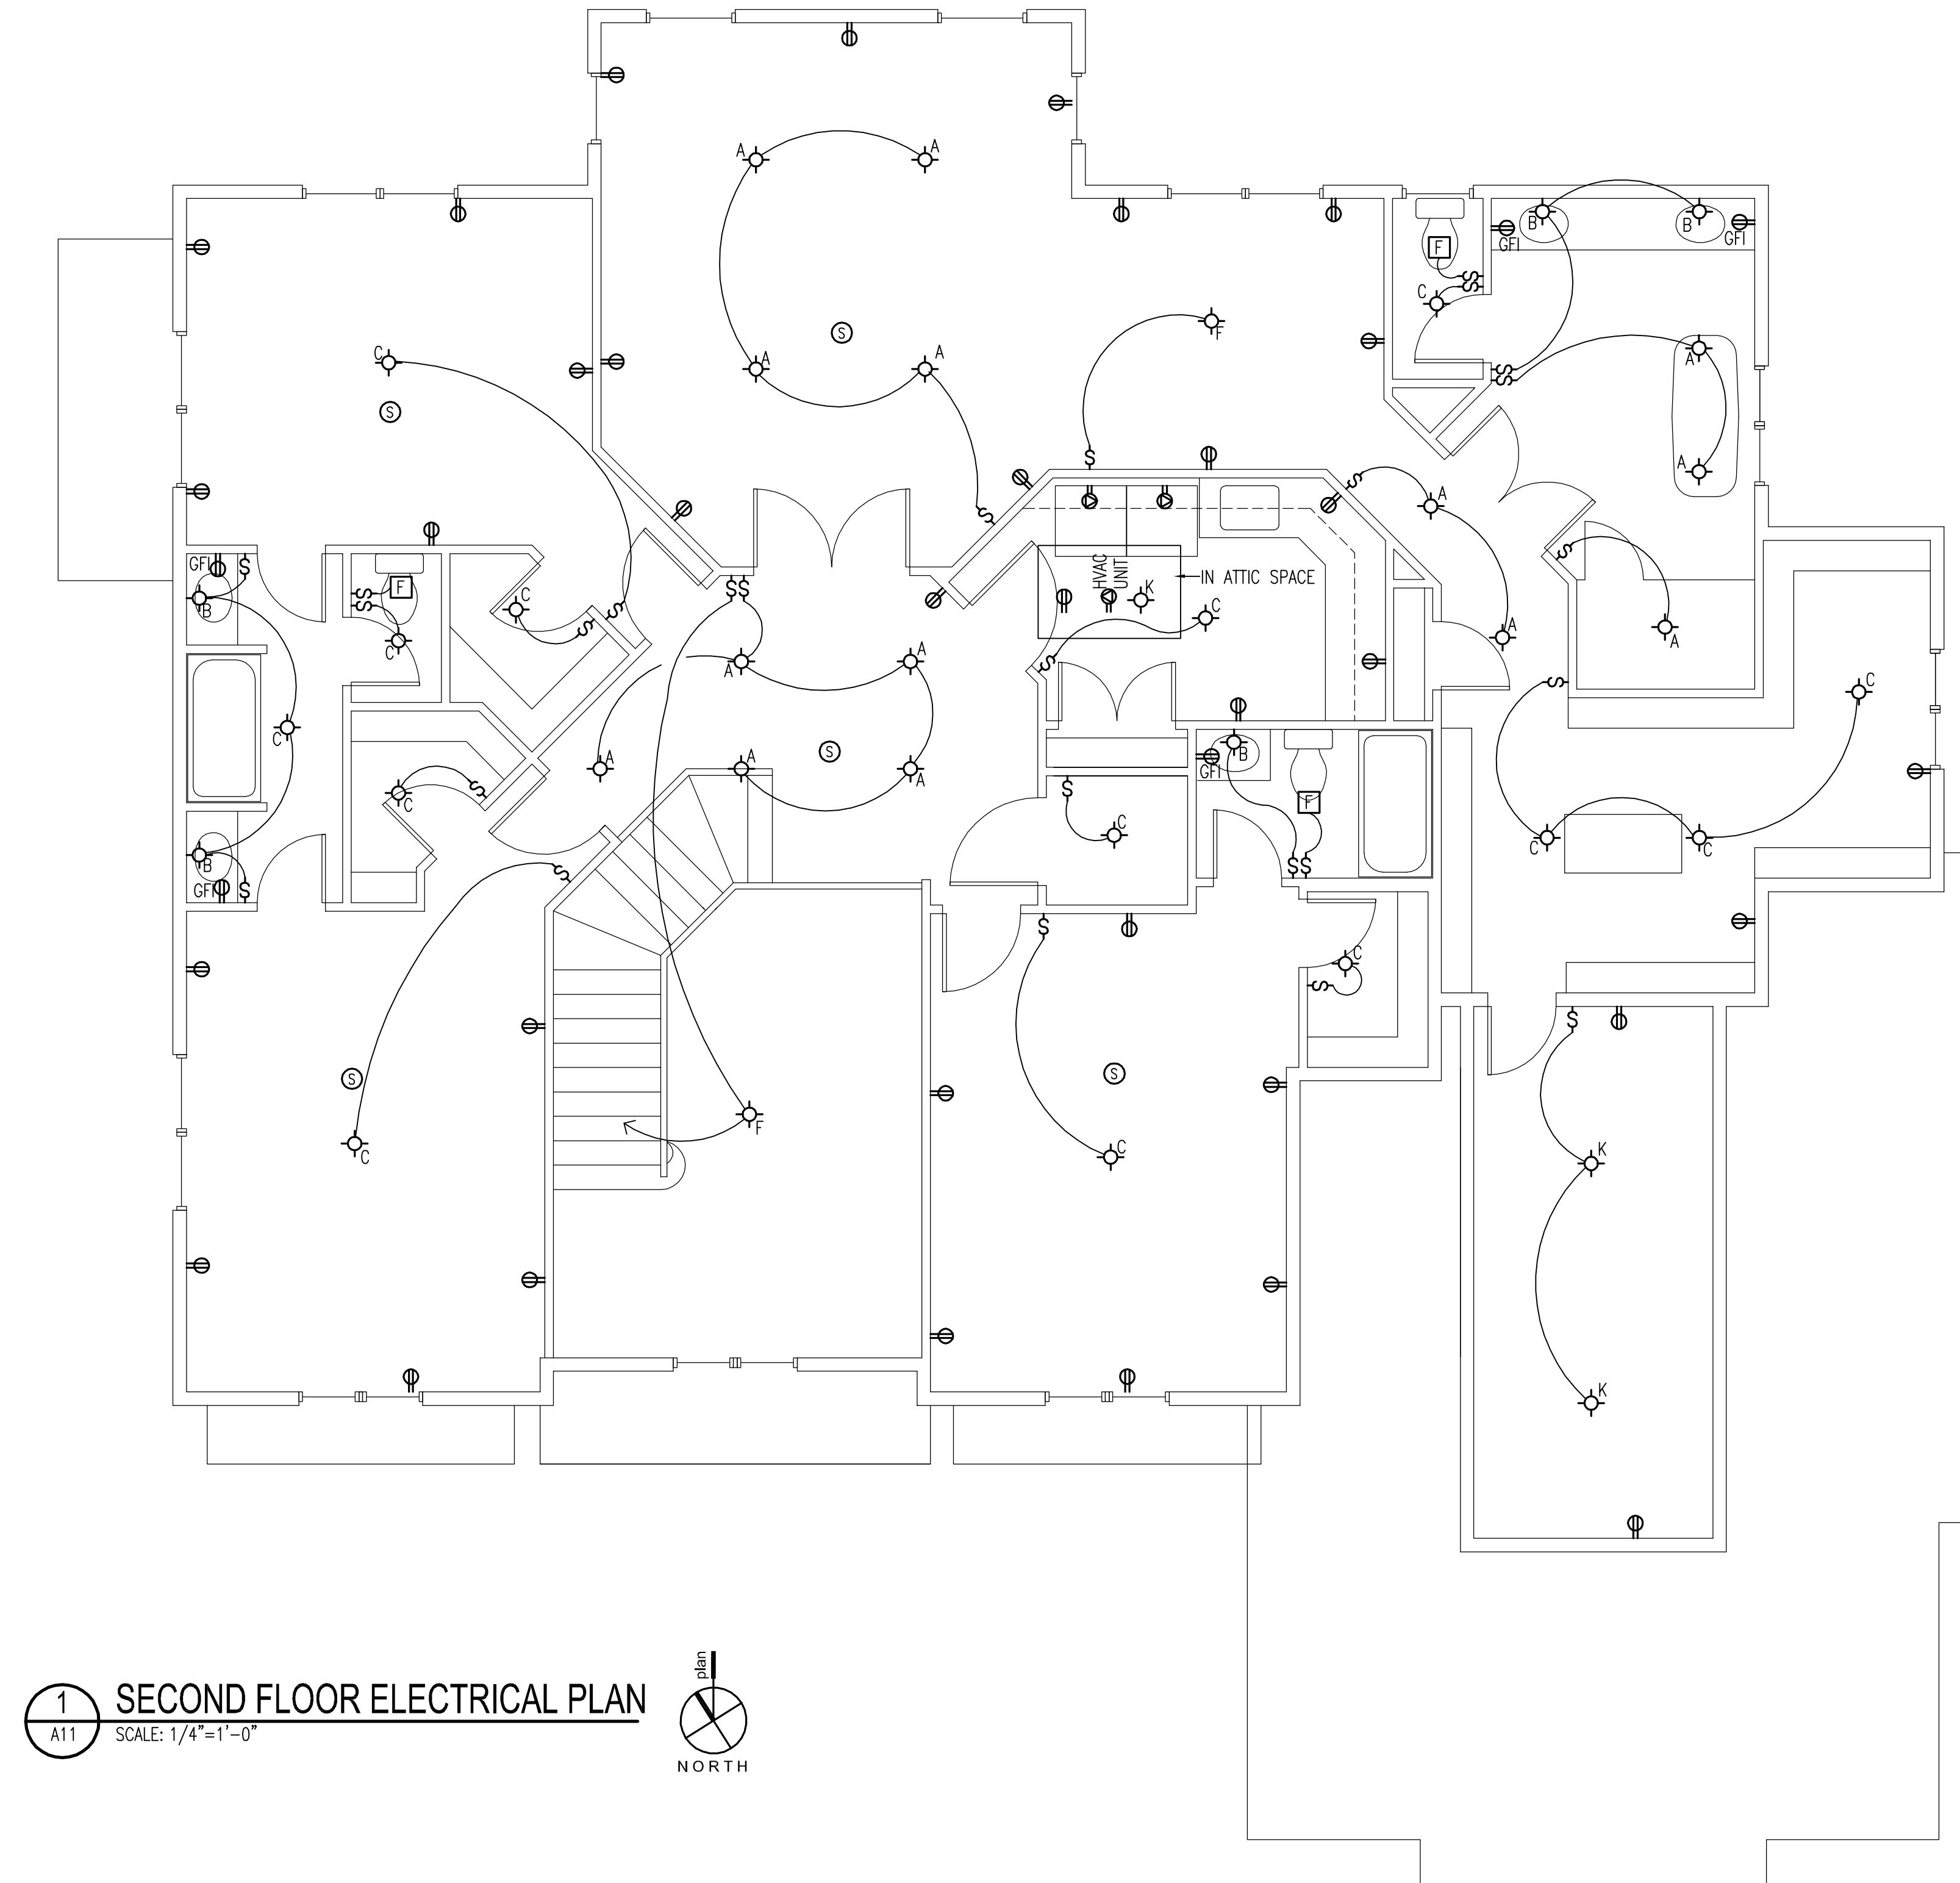

1 SECOND FLOOR ELECTRICAL PLAN
A11 SCALE: 1/4"=1'-0"

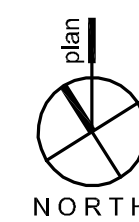

Second Floor Electrical Plan

A11