


LIGHT FIXTURE SCHEDULE


- A CEILING RECESSED DOWNLIGHT
- B WALL MOUNTED STRIP FIXTURE
- C SURFACE MOUNTED CEILING FIXTURE
- D PENDANT MOUNTED DOWNLIGHT
- E CEILING RECESSED SPOT LIGHT
- F PENDANT MOUNTED CHANDELIER
- G WALL MOUNTED SCONCE
- H CEILING MOUNTED FIXTURE AT GARAGE
- I WALL MOUNTED EXTERIOR FIXTURE
- J LINEAR UNDERCABINET FIXTURE
- K CEILING MOUNTED UTILITY LIGHT
- L WALL MOUNTED UTILITY LIGHT
- M EXTERIOR RECESSED CEILING DOWNLIGHT

SYMBOLS LEGEND

- ⊕ DUPLEX ELECTRIC OUTLET
- GFI ⊕ GROUND FAULT CIRCUIT INTERRUPT OUTLET
- ⊕ SWITCHED OUTLET
- ⊕ QUAD ELECTRIC OUTLET
- WP ⊕ WATERPROOF ELECTRIC OUTLET
- ⊕ SPECIAL ELECTRIC CONNECTION OR APPLIANCE
- ⊕ FLOOR RECESSED DUPLEX ELECTRIC OUTLET
- ⊕ SWITCH
- ⊕ DIMMER SWITCH
- ◇ DOOR JAMB SWITCH
- ⊕ LIGHT FIXTURE
- ⊕ WALL WASHER LIGHT
- STRIP LIGHT (UNDERCABINET, COVE)
- ⊕ CEILING FAN
- ⊕ SMOKE & CARBON MONOXIDE DETECTOR
- ⊕ EXHASUT FAN WITH DUCT TO EXTERIOR

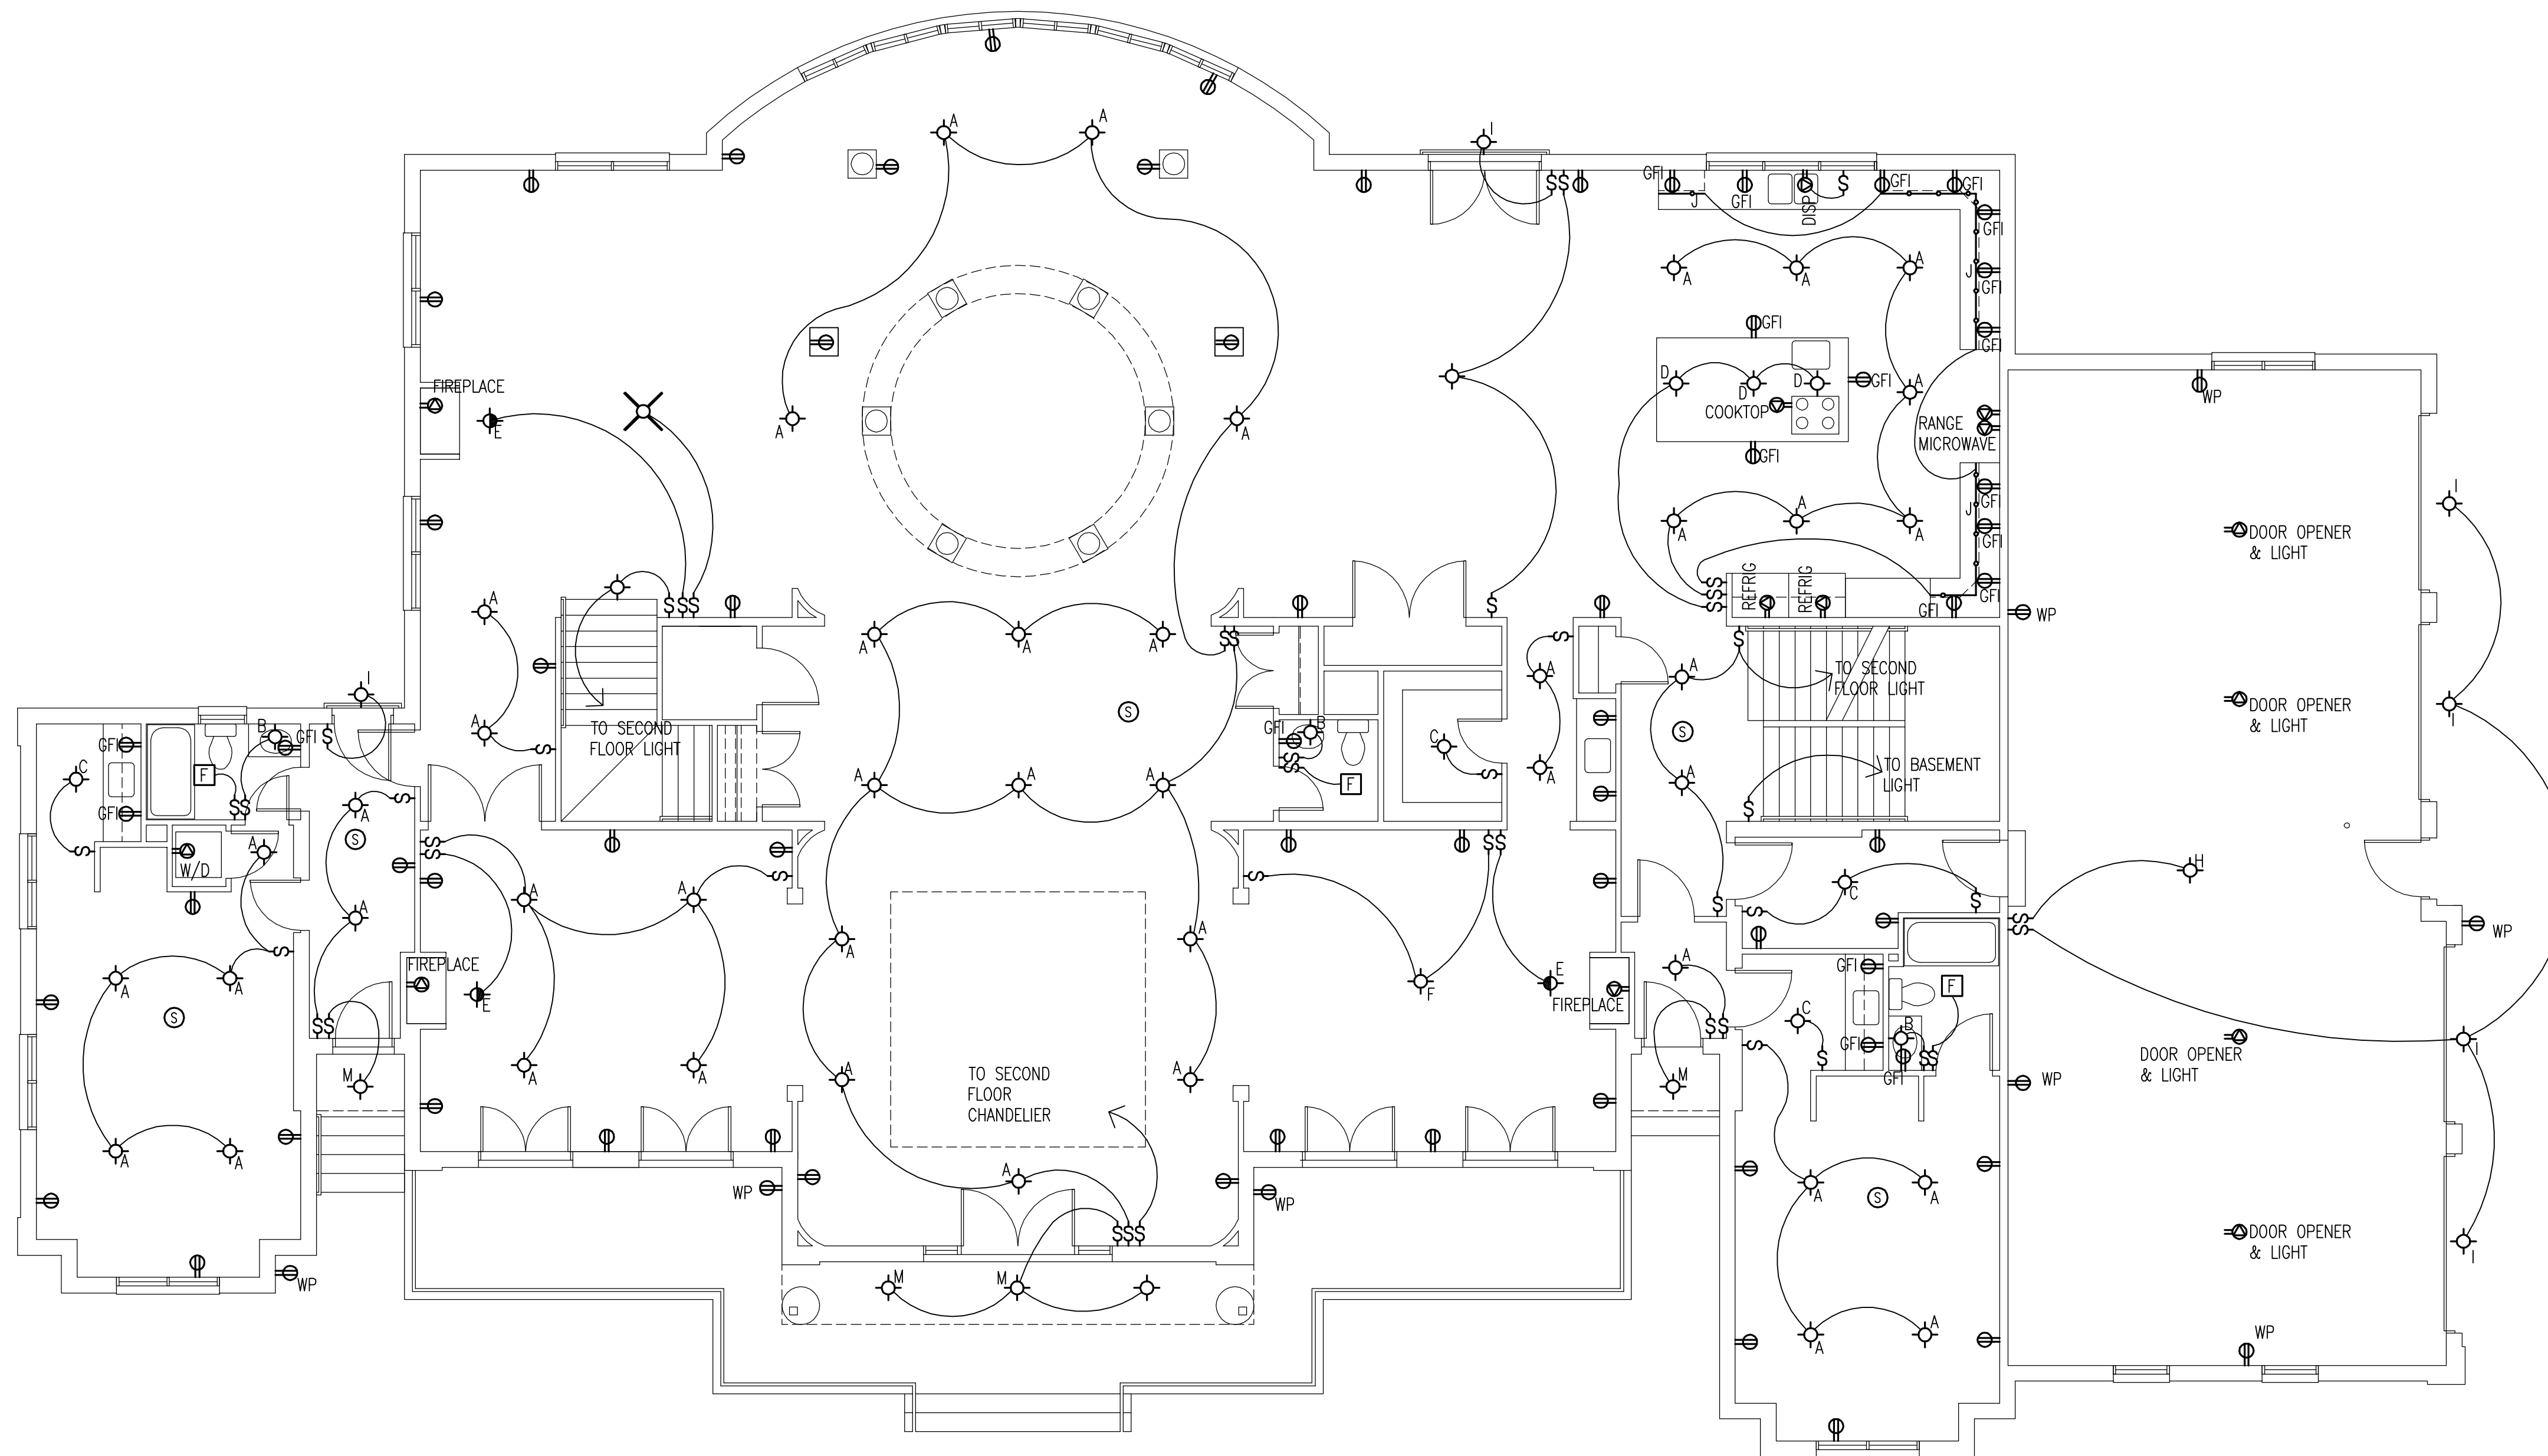

1 FIRST FLOOR ELECTRICAL PLAN
 A10 SCALE: 3/16"=1'-0"
 NORTH

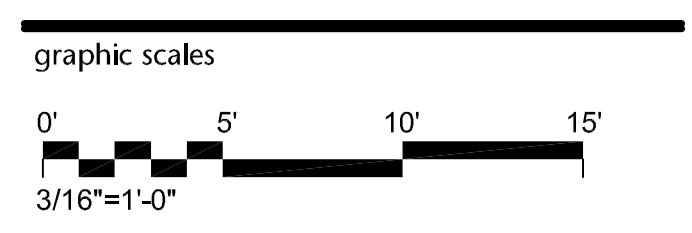

project: 24712
 phase: Permit
 date: 8 November 2018
 revisions:

First Floor
 Electrical Plan

Residence

931 Old Dominion Drive
 McLean, Virginia 22102

NOVITSKE ARCHITECTS

201 North Fairfax Street • Suite 33
 Alexandria VA 22314
 703 535 7899 • 703 535 8840 fax