




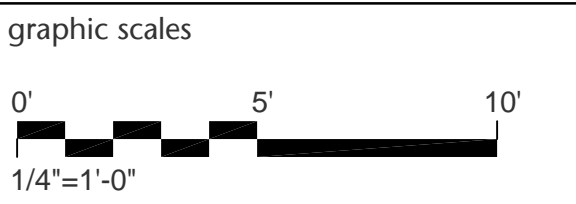

I CERTIFY THAT THESE DOCUMENTS WERE PREPARED BY OR APPROVED BY ME AND THAT I AM A DULY LICENSED PROFESSIONAL ENGINEER UNDER THE LAWS OF THE STATE OF MARYLAND.
LICENSE NUMBER: 16869,
EXPIRATION DATE: March 25, 2016

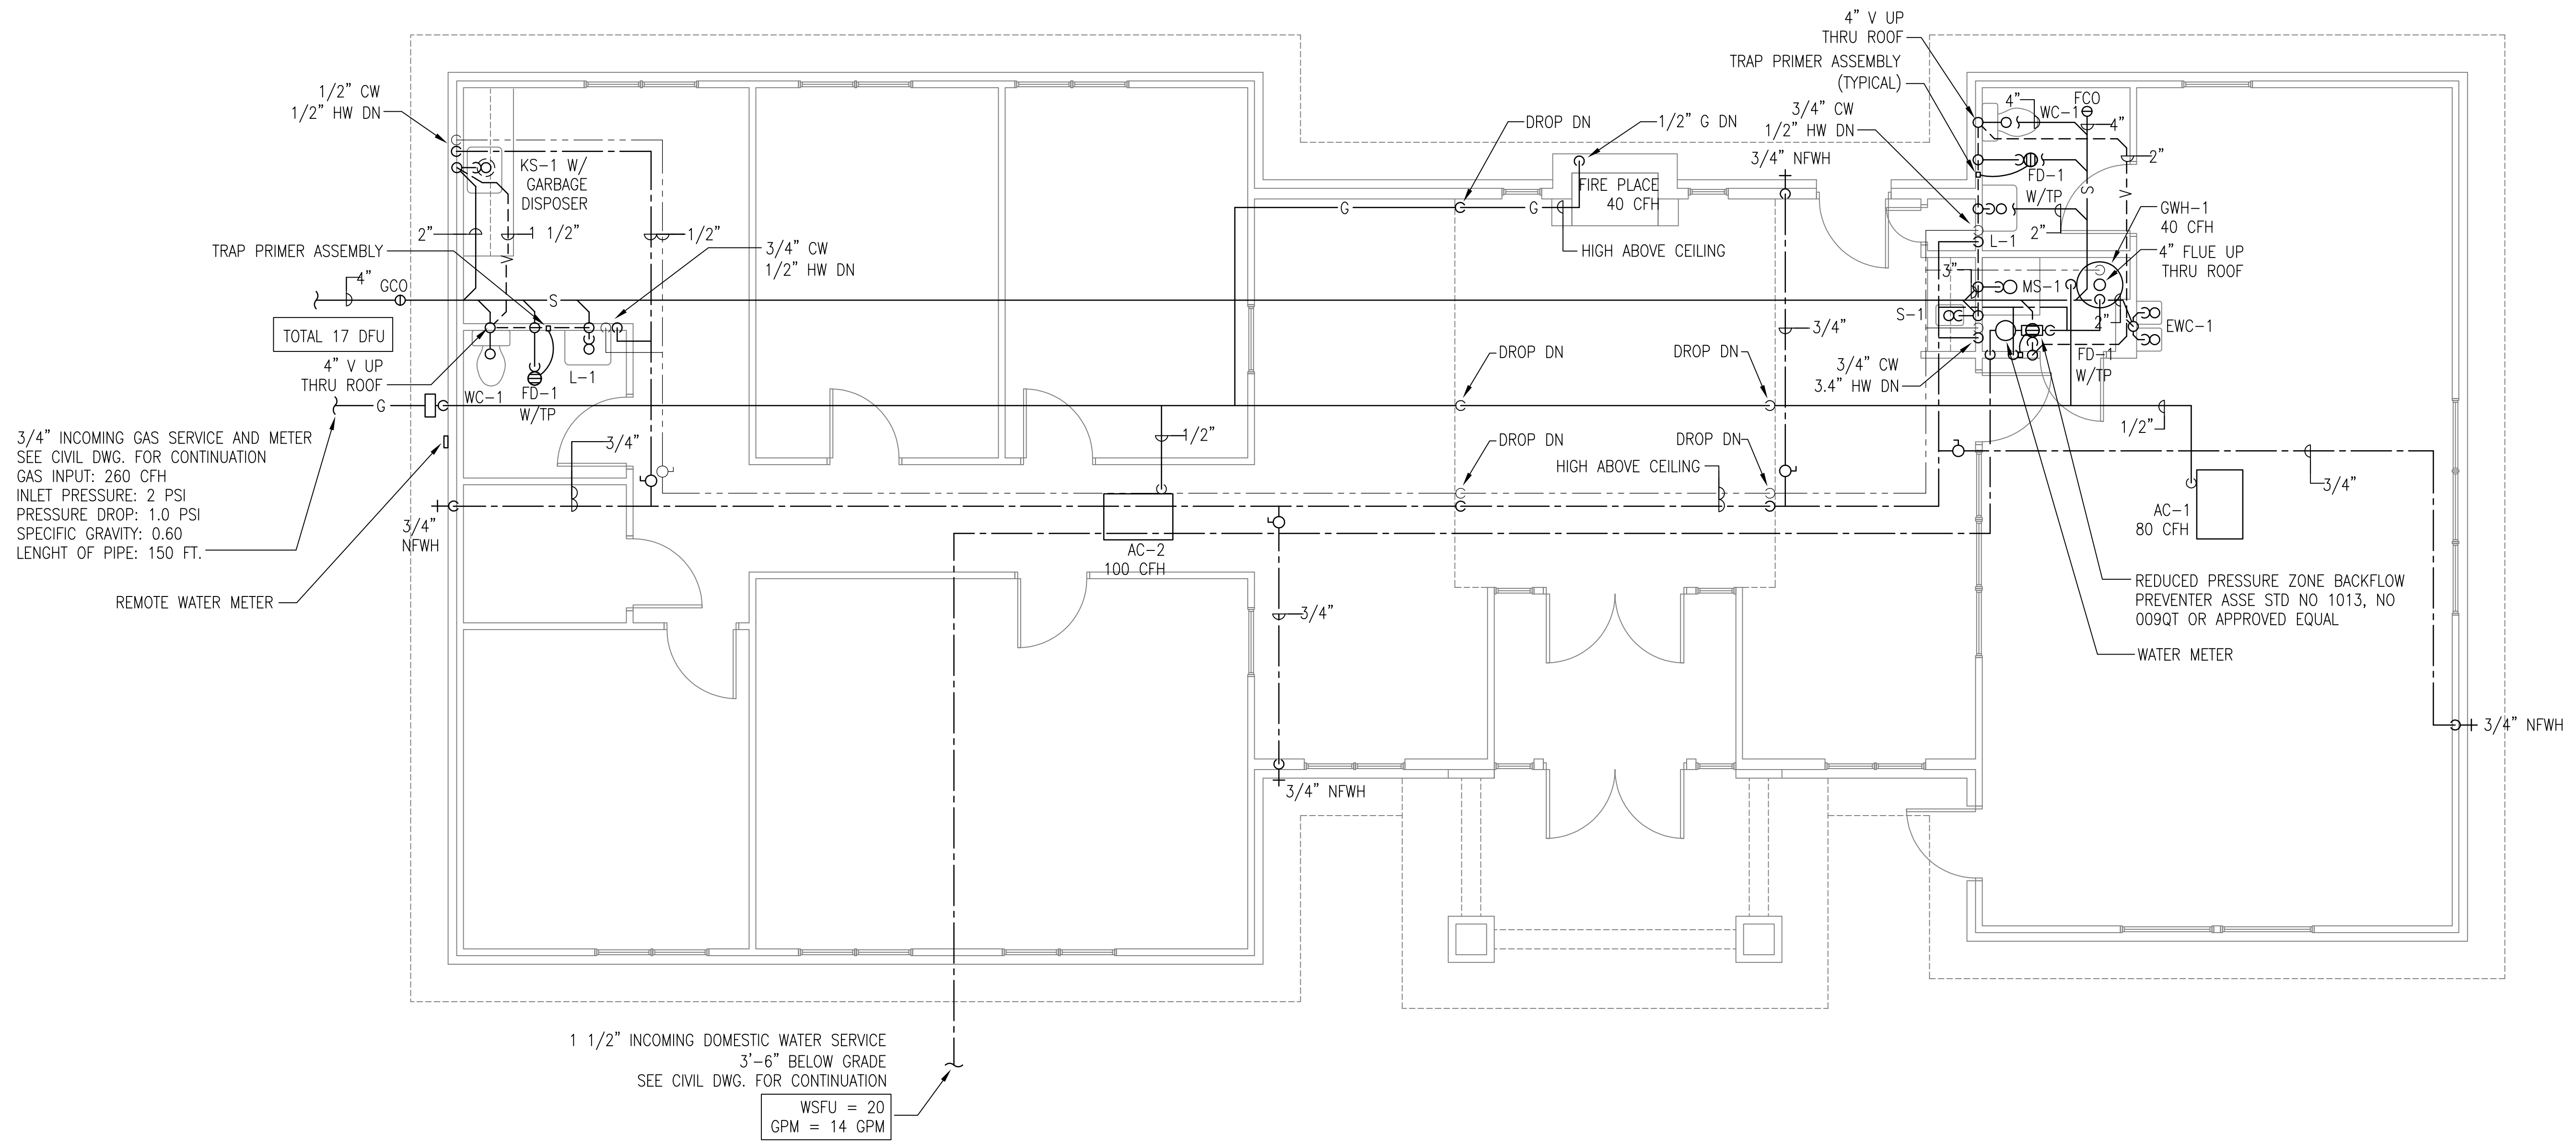

1 PLUMBING FLOOR PLAN
SCALE: 1/4"=1'-0"

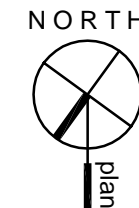

project:	21418
phase:	Permit
date:	17 April 2015
revisions:	