

LEASING OFFICE
CLUB HOUSE

Walker Mill Apartments
1926 Rochelle Avenue
Forestville, Maryland 20747

FEDERAL CAPITAL PARTNERS

5425 Wisconsin Avenue • Suite 202
Chevy Chase MD 20815
240 395 2000


NOVITSKE ARCHITECTS

201 North Fairfax Street • Suite 33
Alexandria VA 22314
703 535 7899 • 703 535 8840 fax




14415 MARINE DRIVE, SILVER SPRING MD. 20905
TEL: (301) 989-9142 FAX: (301) 989-0830
E-MAIL: massoud@ncengineers.com


I CERTIFY THAT THESE DOCUMENTS WERE PREPARED BY
OR APPROVED BY ME AND THAT I AM A DULY LICENSED
PROFESSIONAL ENGINEER UNDER THE LAWS OF THE
STATE OF MARYLAND.
LICENSE NUMBER: 16869,
EXPIRATION DATE: March 25, 2016

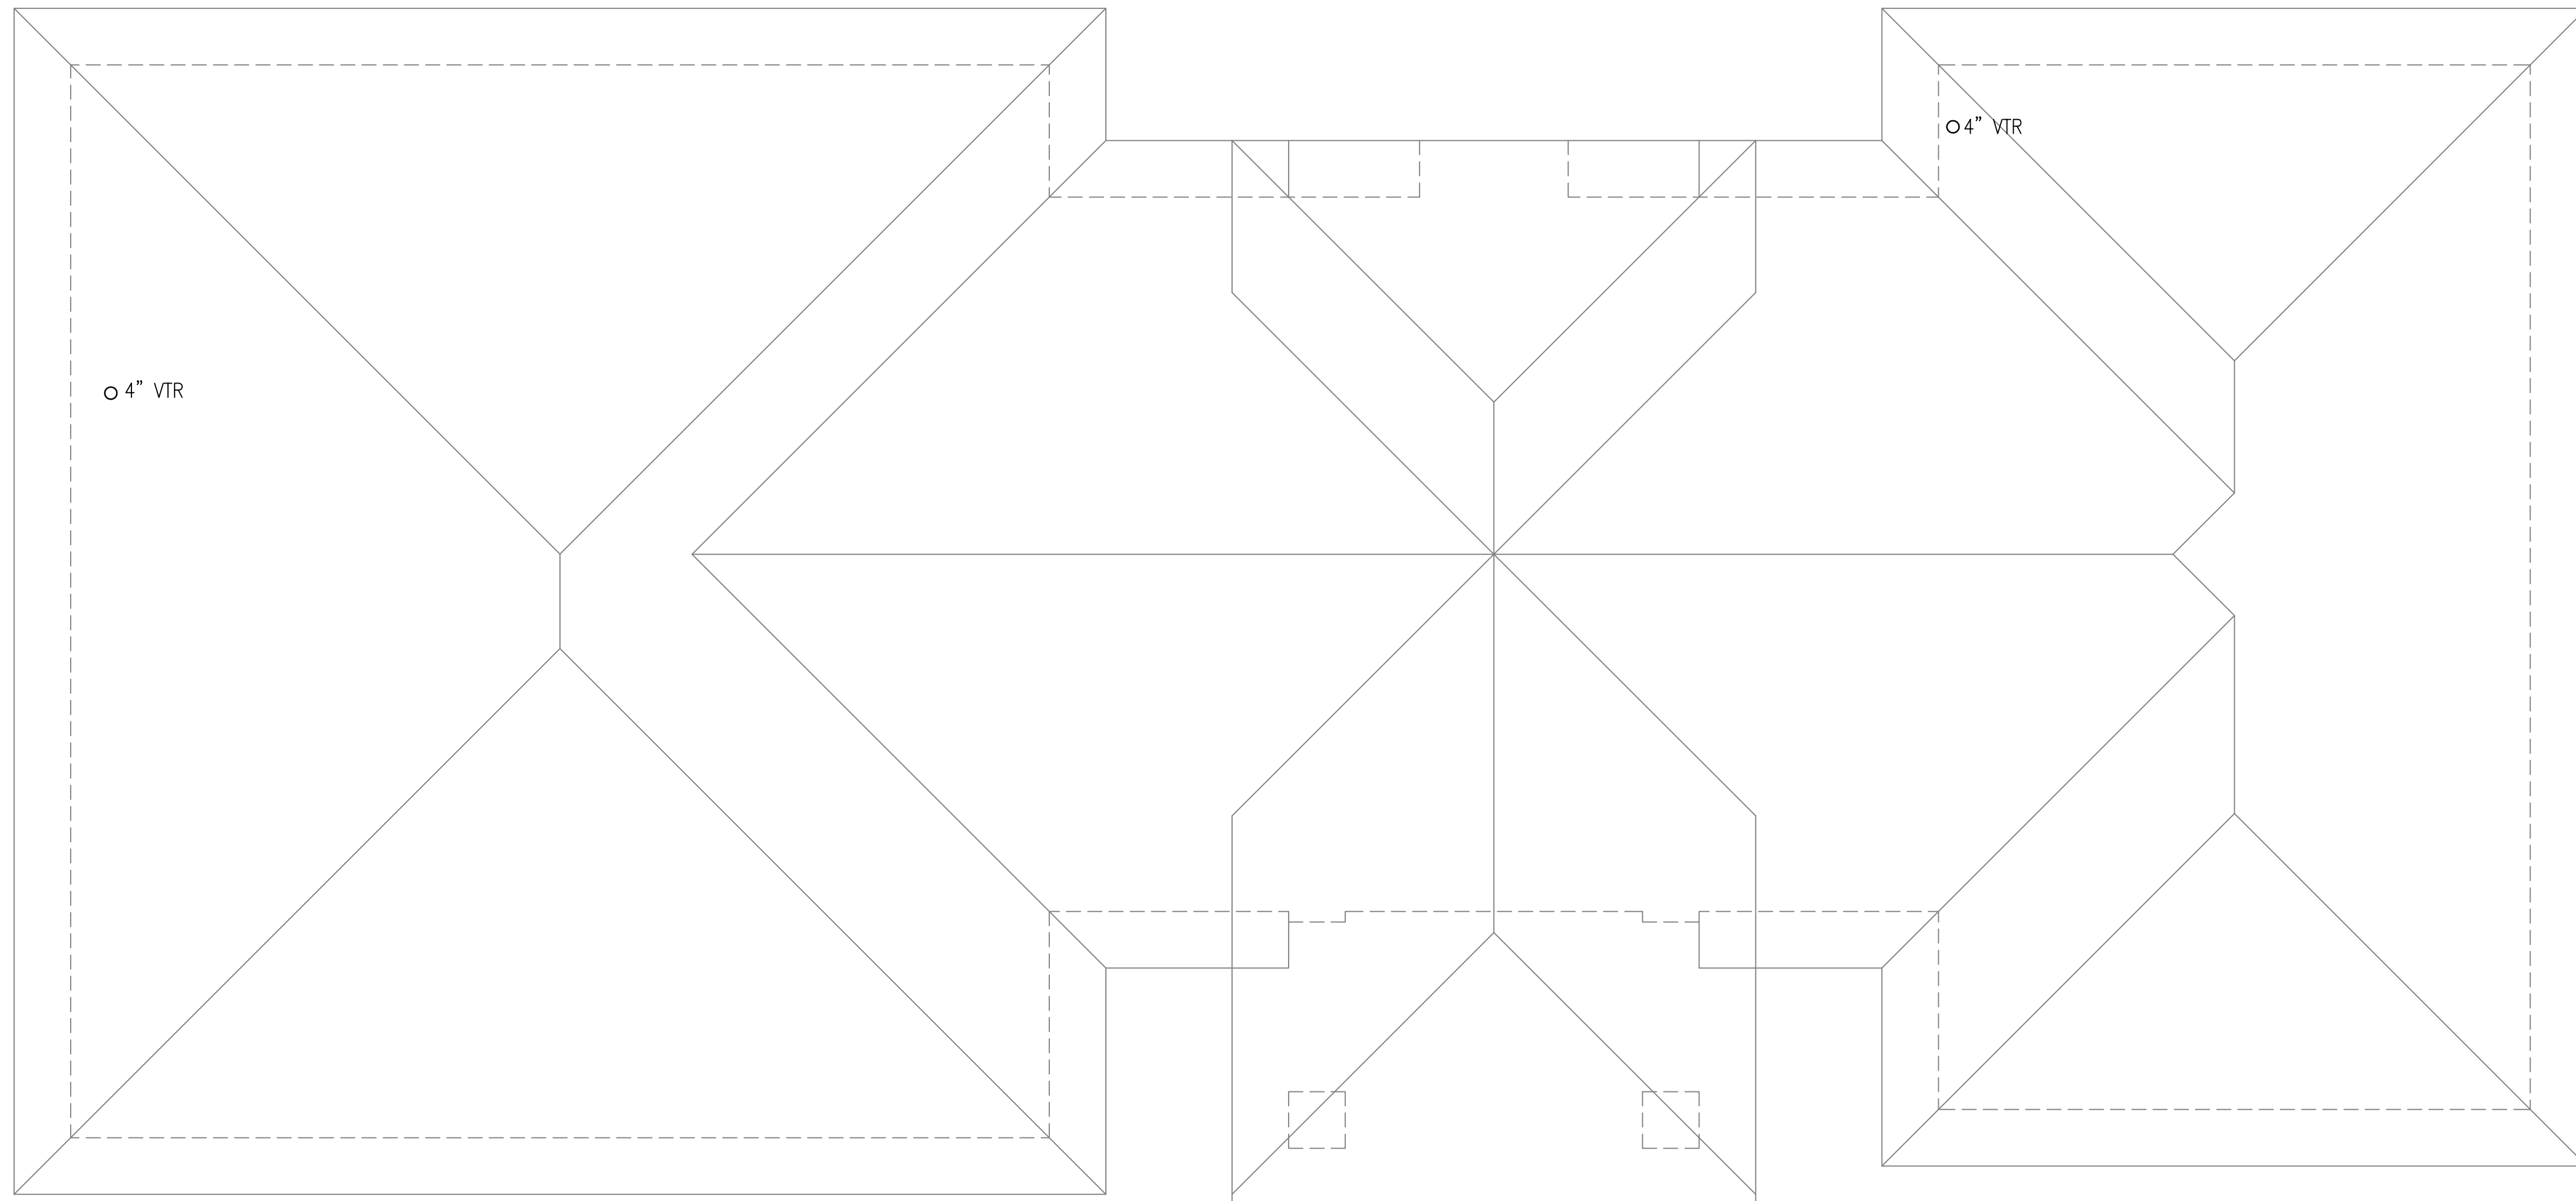

graphic scales

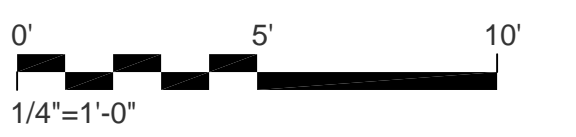

1 PLUMBING ROOF PLAN
P3 SCALE: 1/4"=1'-0"

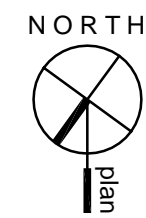

project: 21418
phase: Permit
date: 17 April 2015
revisions:

PLUMBING ROOF PLAN

P3